


LUMINAIRE SCHEDULE / ATODLEN UNEDAU GOLEUO	
	LUMINAIRE REF / UNED OLEUO CYF- A MANUFACTURER / GWNEUTHURWR- THORLUX MODEL / MODEL- REALTA (WALL MOUNTED) SPECIFICATION / MANYLION - 8W, 3000K, POLYCARBONATE COVER,WIDE DISTRIBUTION, SMART, EMERGENCY.
	LUMINAIRE REF / UNED OLEUO CYF- A MANUFACTURER / GWNEUTHURWR- THORLUX MODEL / MODEL- REALTA (COLUMN MOUNTED 4m) SPECIFICATION / MANYLION - 8W, 3000K, POLYCARBONATE COVER,WIDE DISTRIBUTION, SMART.
	LUMINAIRE REF UNED OLEUO CYF- C MANUFACTURER / GWNEUTHURWR- THORLUX MODEL / MODEL- STARBEAM SPECIFICATION / MANYLION - 31W, 3000K, AREA DISTRIBUTION, SMART.
	SINGLE HEAD COLUMN MOUNTED LUMINAIRE / UNED OLEUO COLOFN UNIGOL "X" DENOTES LUMINAIRE REFERENCE / CYFEIRNOD UNED OLEUO "Nm" DENOTES COLUMN HEIGHT / UCHDER UNED OLEUO
	TWIN HEAD COLUMN MOUNTED LUMINAIRE / UNED OLEUO COLOFN GEFEILLIO "X" DENOTES LUMINAIRE REFERENCE / CYFEIRNOD UNED OLEUO "Nm" DENOTES COLUMN HEIGHT / UCHDER UNED OLEUO
	WALL MOUNTED LUMINAIRE / UNED OLEUO WAL "X" DENOTES LUMINAIRE REFERENCE / CYFEIRNOD UNED OLEUO

ISOLINES

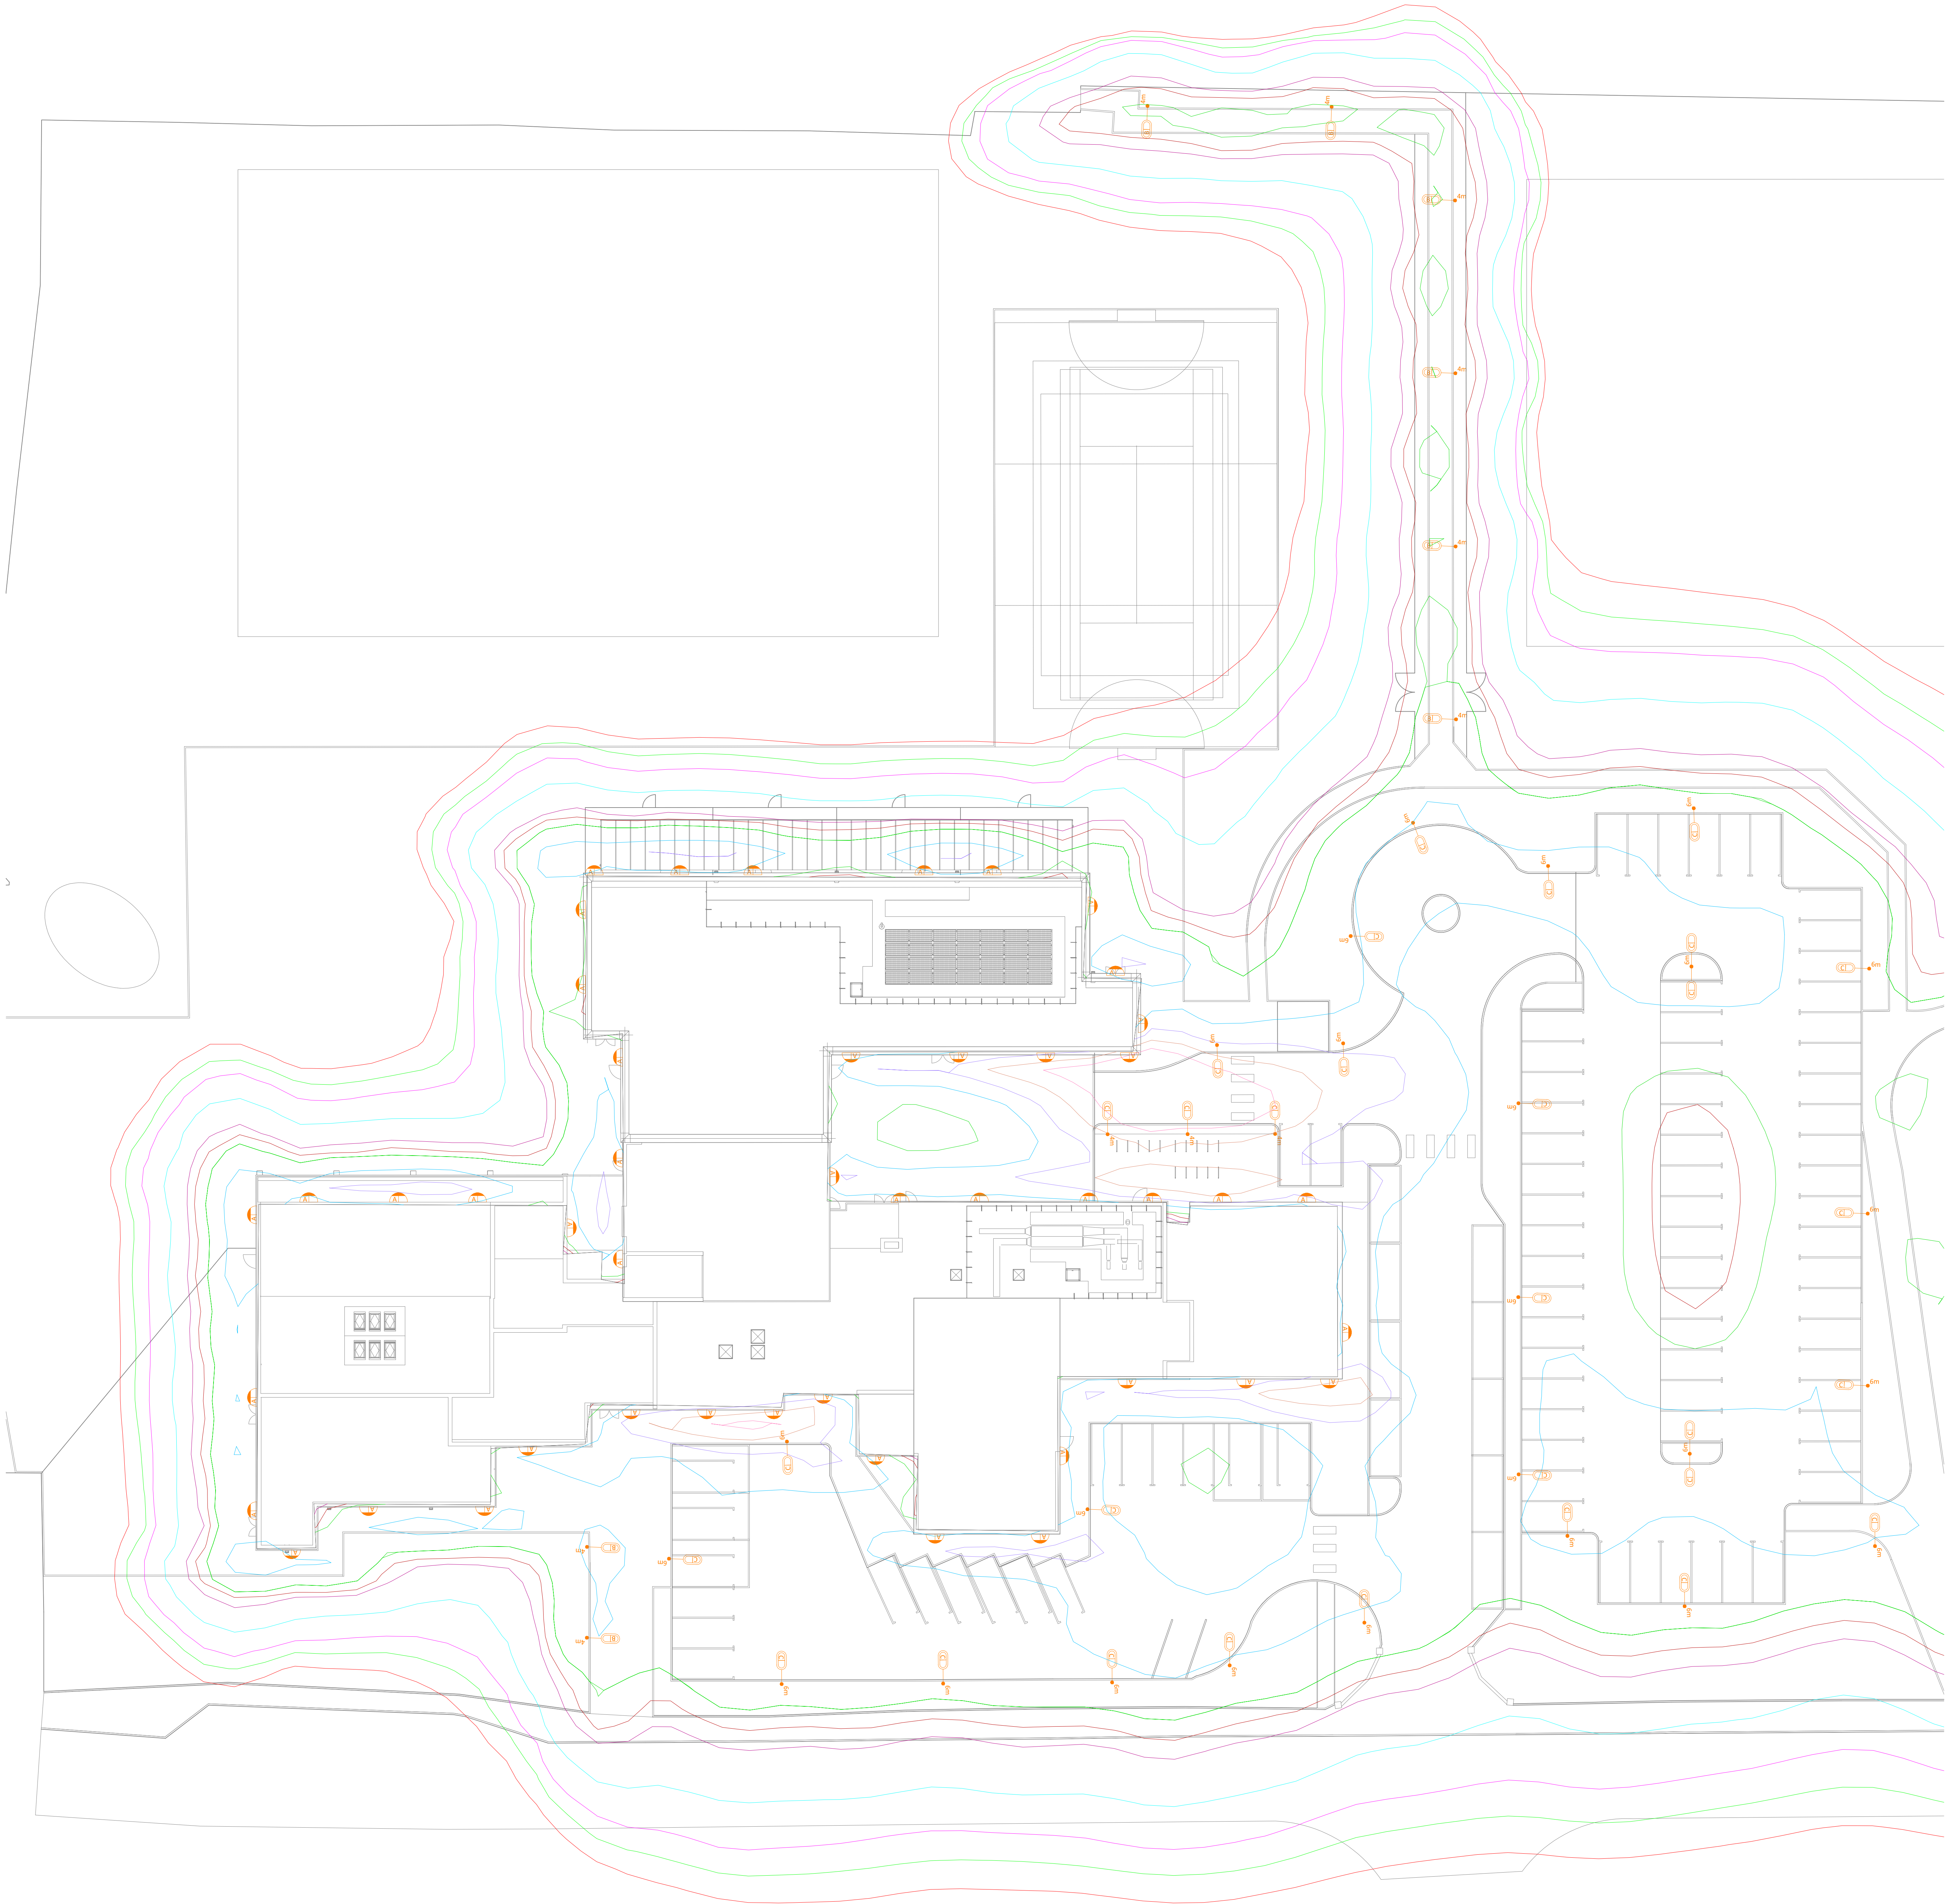

Status	Purpose of Issue
S2	

Client




Project

YSGOL GYNRADD GYMUNEDOL PARC BORRAS / BORRAS CP SCHOOL

Drawing Title

CYNLLUN GOLEUO ALLANOL /  
EXTERNAL LIGHTING LAYOUT  
CYNLLUN 1 OR 2 / SHEET 1 OF 2

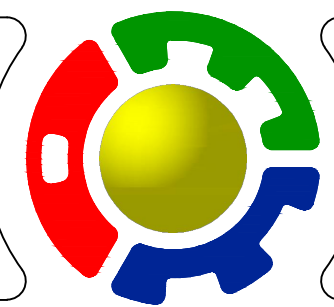

**DAVIES PARTNERSHIP**  
BUILDING SERVICES CONSULTING ENGINEERS  
ENVIRONMENTAL | DYNAMIC MODELLING | SUSTAINABLE DESIGN

Cestrian House, Lightfoot Street, Hoole, Chester, CH2 3AD.  
Tel: 01244 315568  
Email - [cad@daviespartnership.co.uk](mailto:cad@daviespartnership.co.uk)  
[www.daviespartnership.co.uk](http://www.daviespartnership.co.uk)



Date	10/05/20	Scale	1:200 @ A0	Eng	MR
Drw. No.	BOR-DPL-A0-XX-DR-E-0003	CAD		Rev.	P03